


© AHARONIAN & ASSOCIATES INC 2012

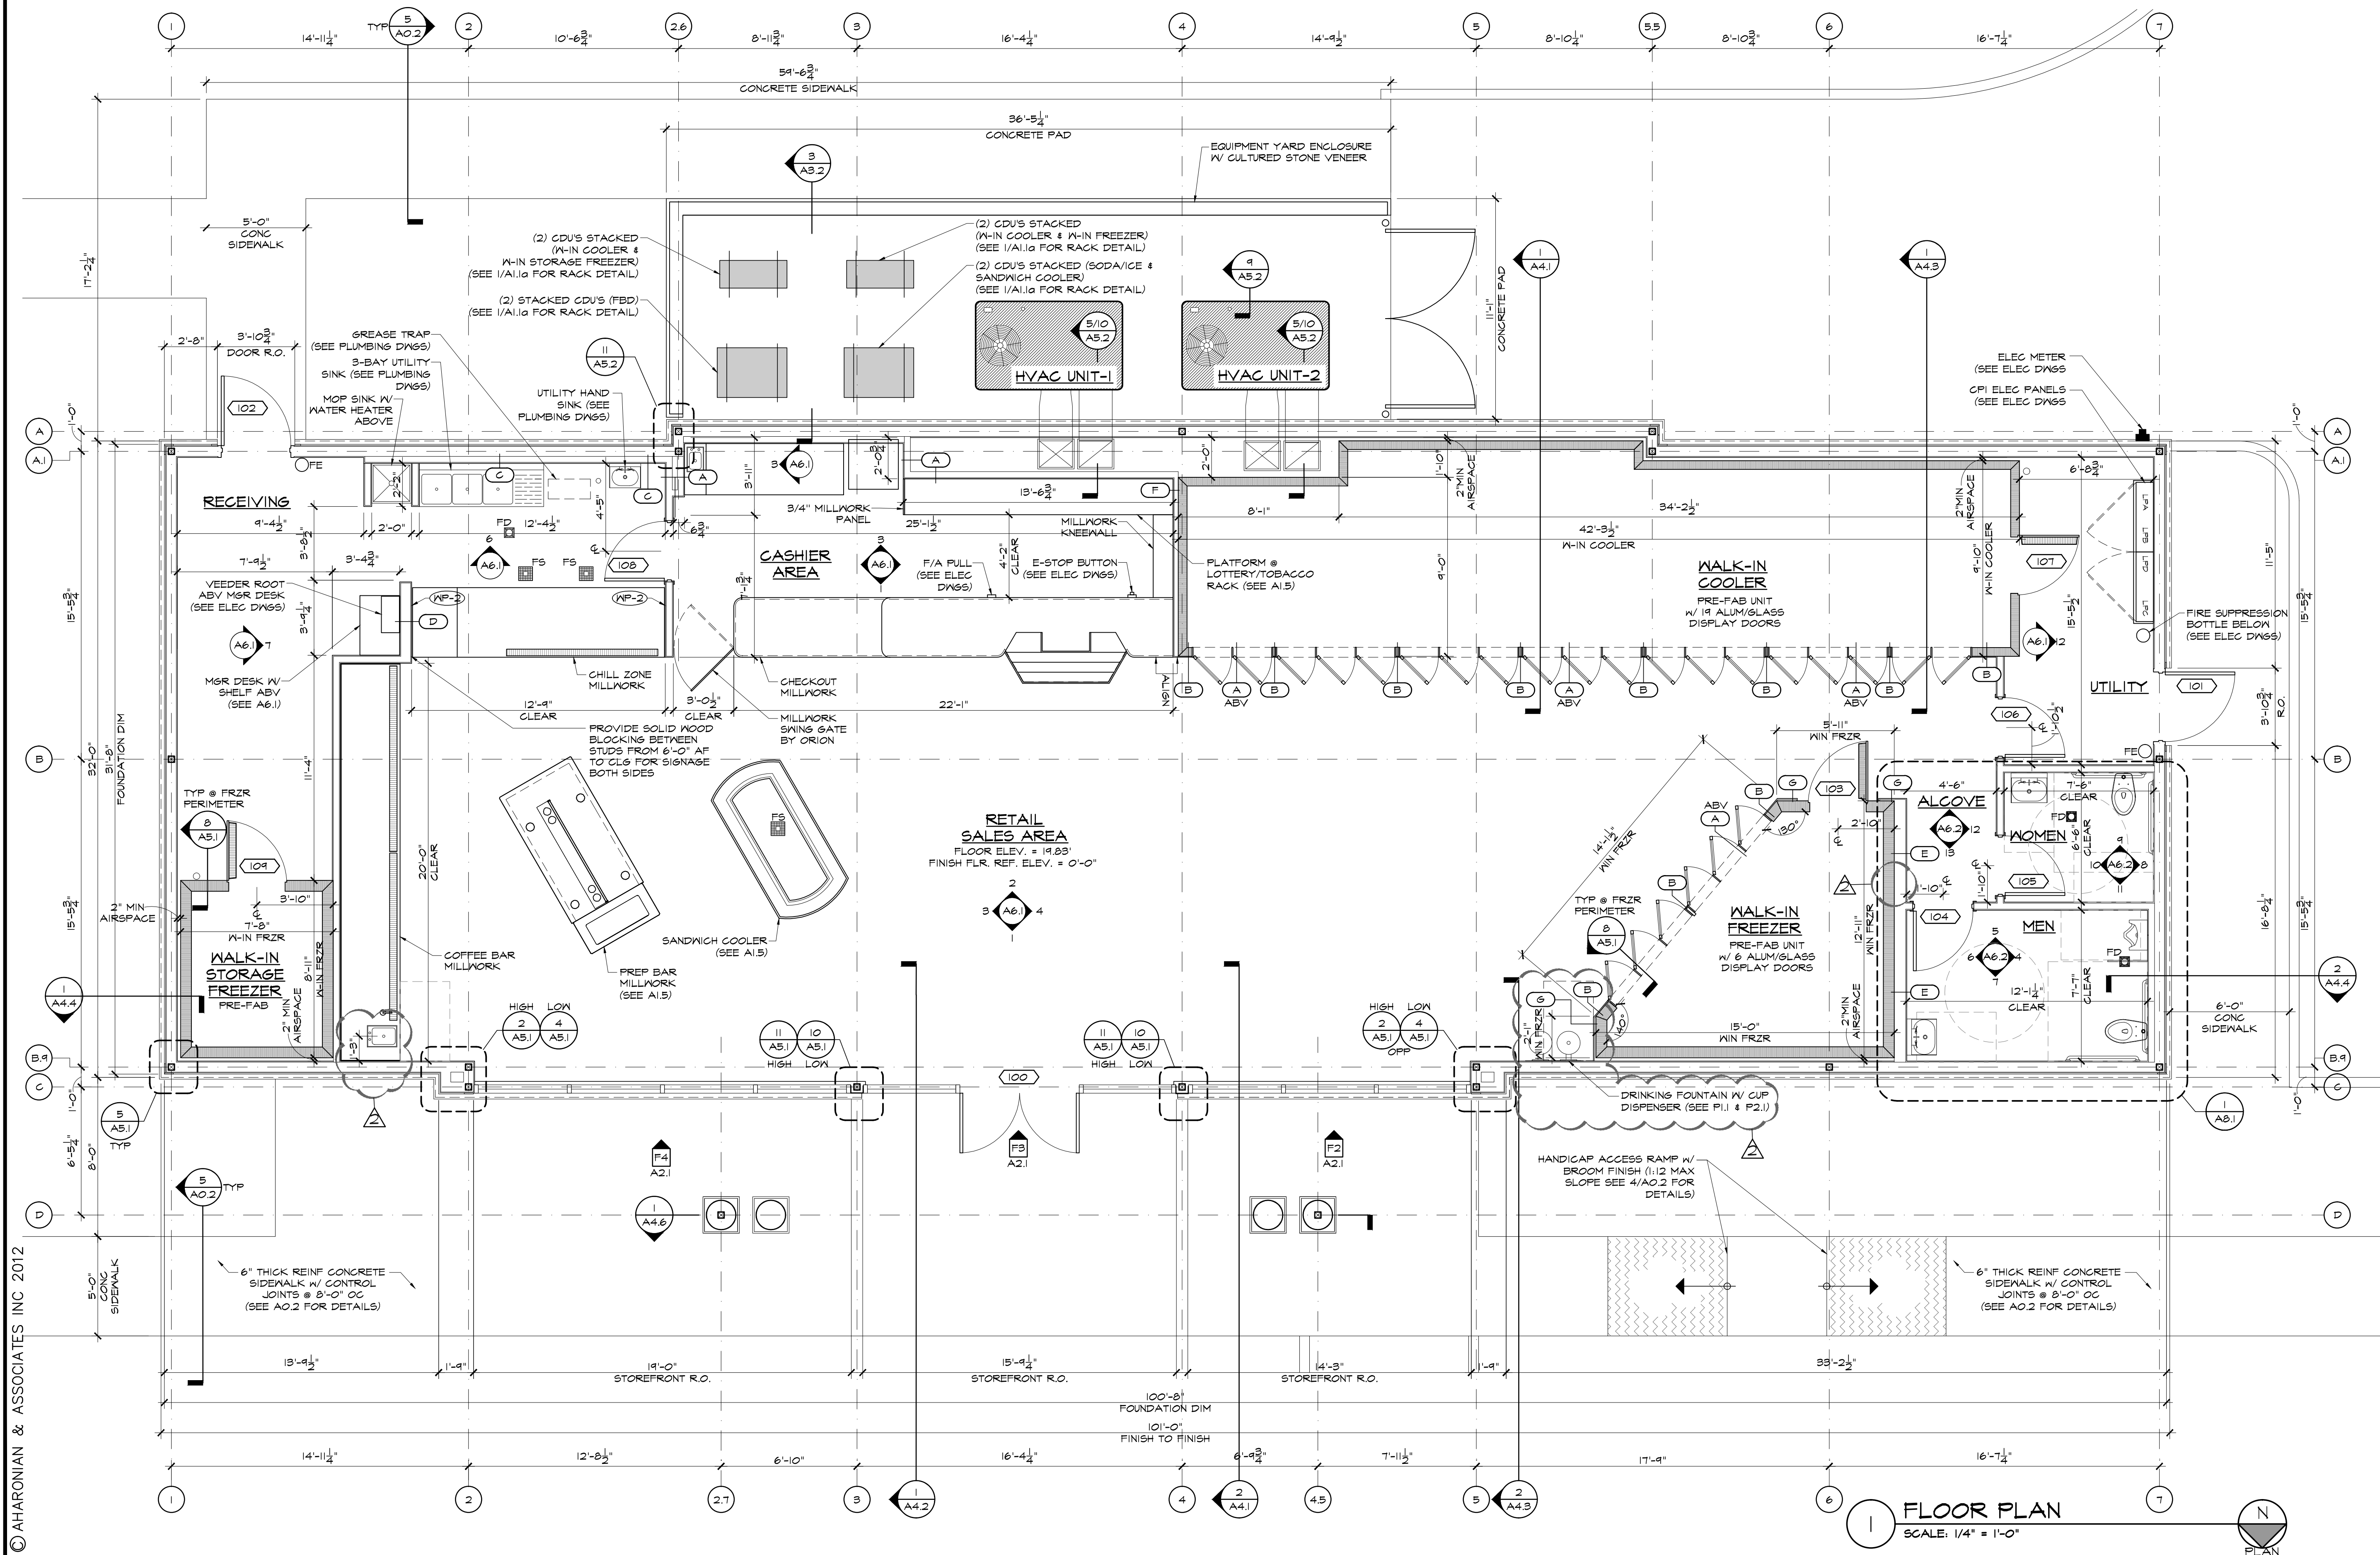


SPECIFICATIONS

BUILDING FIRE EXTINGUISHER
LARSON MODEL MP10 10 LBS MULTIPURPOSE DRY CHEMICAL UNIT FIRE EXTINGUISHER (WITH WALL MOUNTING BRACKET), UL RATING 4A-80B:C, OR OTHER APPROVED EQUAL.
FIRE EXTINGUISHERS SHALL BE INSTALLED IN ACCORDANCE WITH NFPA 10 AND MANUFACTURER'S INSTRUCTIONS.
FIRE EXTINGUISHERS SHALL BE INSTALLED BY GENERAL CONTRACTOR WITH FINAL PLACEMENT TO BE COORDINATED IN THE FIELD BY THE CONTRACTOR WITH THE LOCAL AUTHORITY HAVING JURISDICTION.
REFER TO SITE DRAWINGS FOR TYPE AND PLACEMENT OF EXTERIOR MOUNTED FIRE EXTINGUISHERS AND FIRE PROTECTION SYSTEMS.

LEGEND

DOOR NUMBER
SEE A2.1 FOR SCHEDULE & DETAILS
FRAME TYPE
SEE A2.1 FOR DETAILS
PARTITION TYPE
(SEE SHEET A1.10)
ELEVATION
NUMBER/SHEET
FLOOR SINK
(SEE PLUMBING DWGS)
FLOOR DRAIN
(SEE PLUMBING DWGS)
FLOOR CLEAN OUT
(SEE PLUMBING DWGS)
INDIRECT DRAIN
(SEE PLUMBING DWGS)
PRE-FAB COOLER/FREEZER WALL PANEL
FIRE EXTINGUISHER

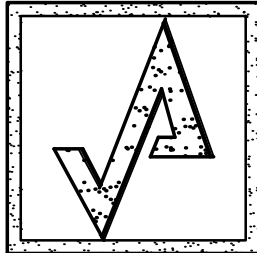

AHARONIAN
& ASSOCIATES INC.
ARCHITECTS

310 George Washington Highway
Suite 100
Smithfield, Rhode Island
0 2 9 1 7
T 401-232-5010
F 401-232-5080
WWW.ARCH-ENG.COM


DISCLAIMER

OWNERSHIP AND USE OF DOCUMENTS, DRAWINGS AND SPECIFICATIONS ARE INSTRUMENTS OF PROFESSIONAL SERVICE AND SHALL REMAIN THE PROPERTY OF THE ARCHITECT. THESE DOCUMENTS ARE NOT TO BE USED, IN WHOLE OR IN PART, FOR ANY OTHER PROJECTS OR PURPOSES OR BY ANY OTHER PARTIES THAN THOSE PROPERLY AUTHORIZED BY CONTRACT WITHOUT THE EXPRESS WRITTEN AUTHORIZATION OF THE ARCHITECT.

REVISIONS

NUMBER	REMARKS	DATE
1	BUILDING DEPARTMENT COMMENTS	12/7/12

FOR PERMIT ONLY

PROJECT TITLE

**Cumberland
Farms**
100 Crossing Blvd, Framingham, Massachusetts
STORE #
V0636
22905 S.R. 7

BOCA RATON, FL
Palm Beach County

DRAWING TITLE

FLOOR PLAN

DATE AUG 29, 2012	PROJ NO 11117
DRAWN BY JJ	CHECKED BY AZ

DRAWING NUMBER

A1.1

FLOOR PLAN
SCALE: 1/4" = 1'-0"