



Yates + Associates Architecture, Inc.


AA-26001673
ARCHITECTURE | PLANNING | INTERIOR DESIGN

1215 South Olive, suite 500 |
West Palm Beach, FL 33401 |
TEL: 561-653-8280 FAX: 561-653-8279 |
EMAIL: Kelly@Yates@bellsouth.net |

HVAC KEY NOTES	
①	CONDENSATE PIPE ABOVE CEILING TO EXTERIOR
②	REF. PIPES IN GALV. ENCLOSURE TO PENETRATE EXISTING ROOF AND TRAVEL THROUGH EXISTING TRUSSES TO PROPOSED AHU LOCATION.
③	4"Ø TOILET EXHAUST DUCT TO ROOF CAP, W/MMS.
④	THERMOSTAT
⑤	not used
⑥	3/4" SCHEDULE 40 PVC CONDENSATE DRAIN PIPE ABOVE GROUND, RUN TO DRYWELL OR GRASSY AREA. 2" UNDERGROUND TO GOOSENECK. SEPARATE MIN. 12" FROM WALL PROVIDE "P" TRAP AT UNIT CONNECTION, INSULATE WITH 1/2" ARMAFLEX A.G. (AT REAR OF BUILDING - VERIFY)
⑦	not used
⑧	MIX BOX ABOVE CEILING

AIR TERMINAL SCHEDULE				
SYMBOL	USE	TYPE	ACCESSORIES	MFG'R. & MODEL
A	SUPPLY AIR	CEILING DIFFUSER	22X22 LAY-IN FRAME, O.B.D.	TITUS PCS-AA
B	SUPPLY AIR	CEILING DIFFUSER	SURFACE MOUNTED FRAME, O.B.D.	TITUS 250-AA
C	RETURN AIR	CEILING FILT. GRILLE	2' X 2' LAY-IN FRAME	TITUS 50FF

NOTE: ALL AIR DISTRIBUTION SHALL BE FINISHED WHITE BAKED ENAMEL

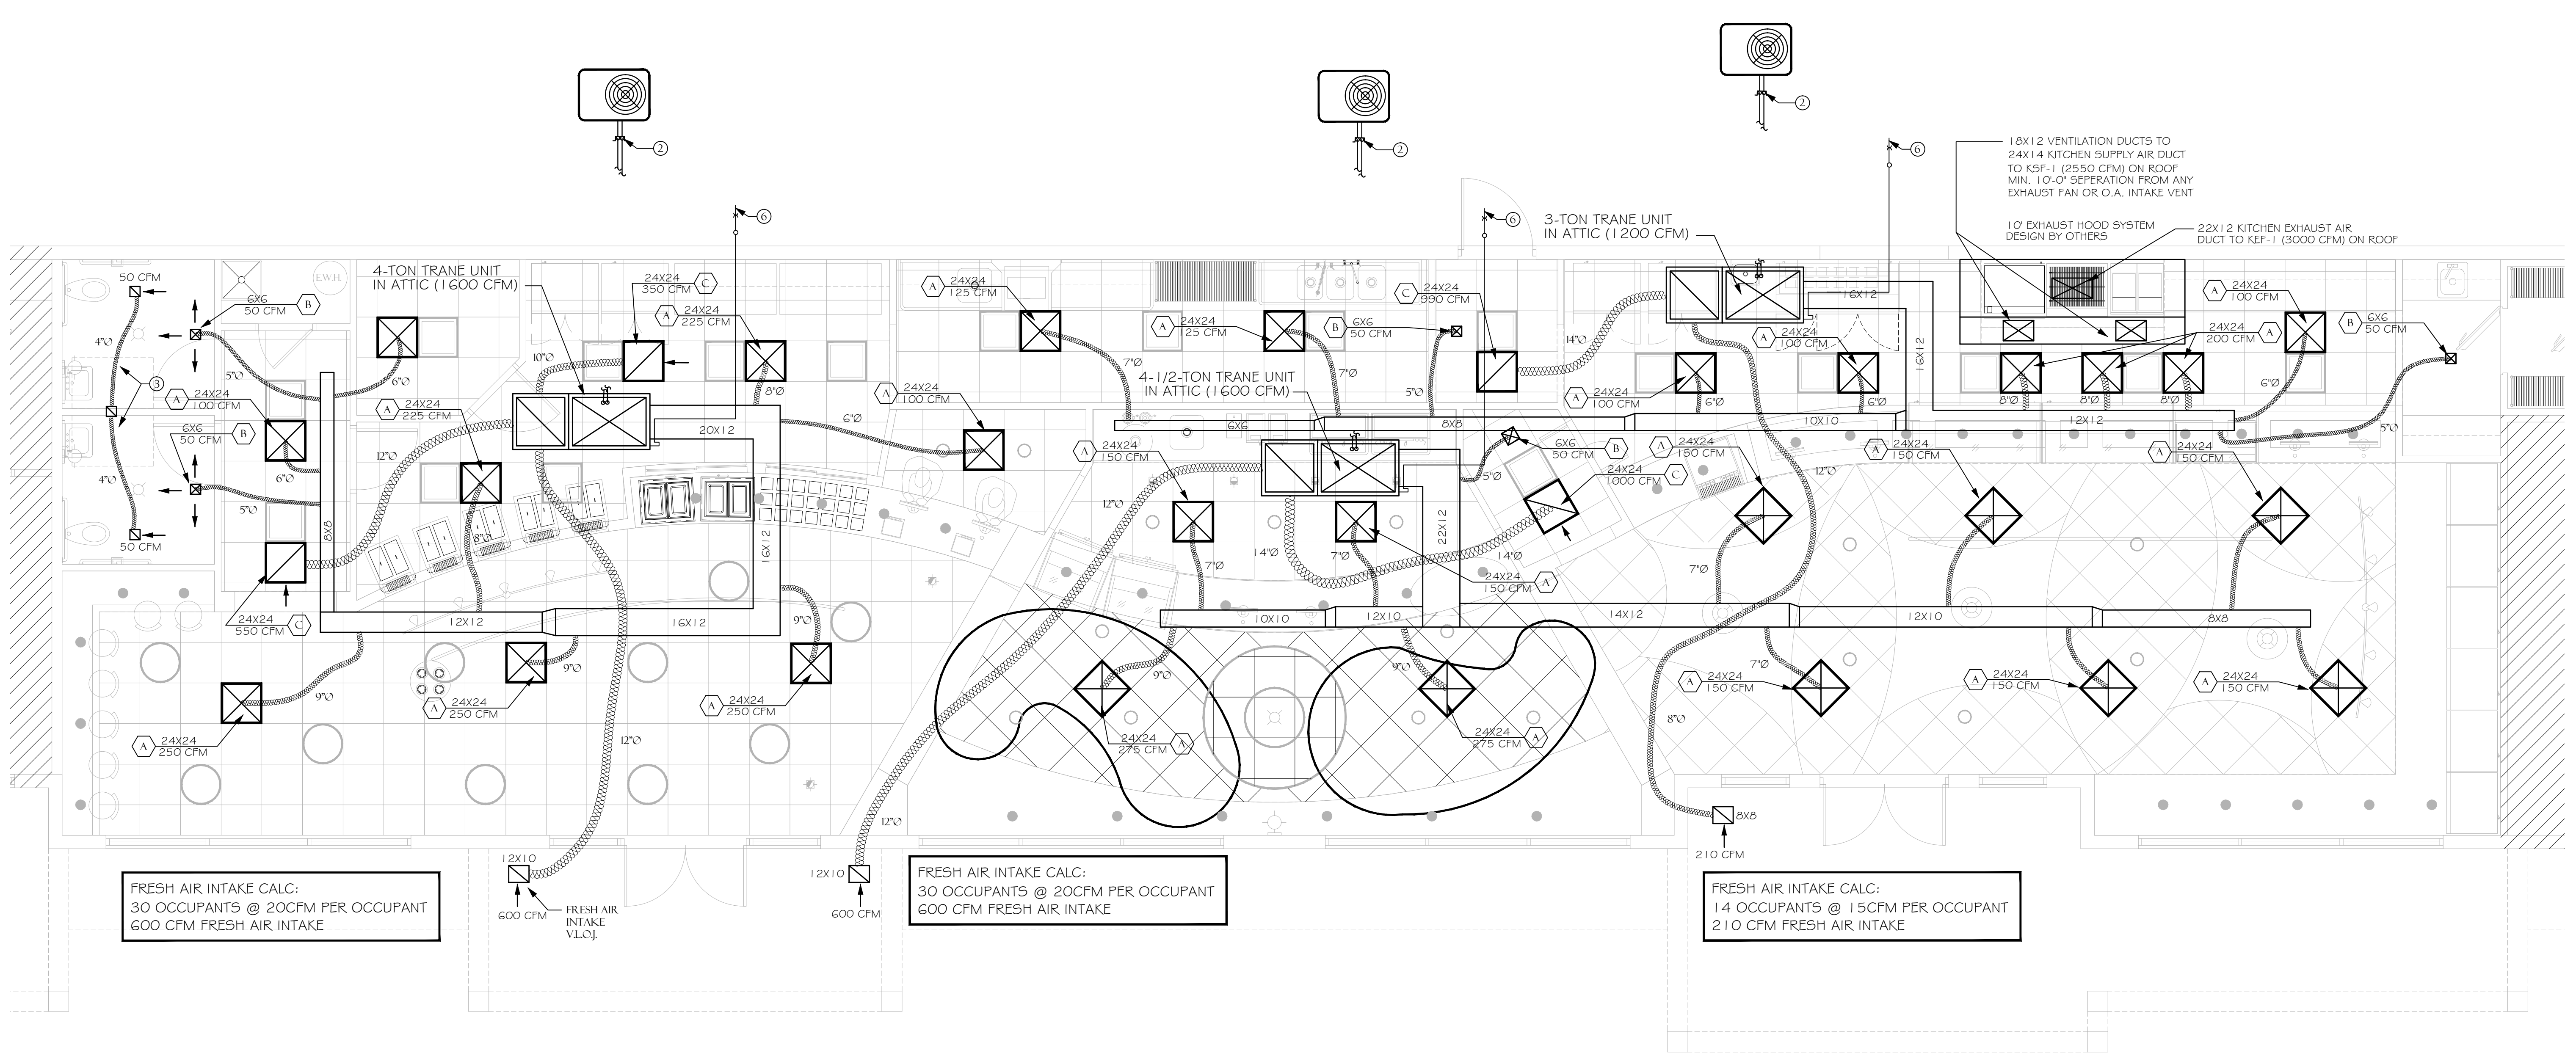

DATE: APRIL 14, 2011
 JOB NO.: 11-0412
 DESIGN BY: K.D.Y.
 DRAWN BY: D.C.M.
 APPROVED: K.D.Y.
 REVISIONS:

A NEW RESTAURANT FOR:
WELLY DELI
 STREET ADDRESS
 CITY JURISDICTION

80%
 REVIEW
 SET
 8-8-11

SEAL

KELLY D. YATES
 FLORIDA AR 13706

SHEET NO.

M-1

OF 8 SHTS
 Eqr (18 j v1 422: Mch T 01 cgs Crg) hgyv

MECHANICAL PLAN
 SCALE : 1/4" = 1'-0"