

MECHANICAL PLAN
UNDER FLOOR DISTRIBUTION

1/4"=1'-0"

KEY NOTES

- 1. EXISTING UNDERFLOOR AIR HIGHWAY LOOP TO REMAIN.
- 2. EXISTING MOTORIZED DAMPER TO REMAIN.
- 3. EXISTING FIRE DAMPER TO REMAIN.

GENERAL NOTES

- 1. REFER TO SHEETS M2.2 FOR ABOVE CEILING AIR DISTRIBUTION AND RETURN AIR PATH.
- 2. CONTRACTOR TO COORDINATE ALL RAISED FLOOR PENETRATIONS WITH CLIENT.


ISSUED FOR PERMIT	
KAMM CONSULTING PROJECT #: 2013-0919 PROJECT MANAGER: DUANE MILLAR	
KAMM Consulting 1408 Orange Avenue Fort Pierce, Florida 34950 Phone 772.595.1744 Fax 772.595.1745 engineering@kammconsulting.com Certification of Authorization #8189	
PRINCIPAL Bradly L. Brown	Florida License #58232
date	signed

Sheet title: MECHANICAL PLAN	revisions:
file name:	
project no:	
date:	
drawn by:	
checked by:	

M2.1

Tenant Improvements for:
NOVATIONS
@ECOPLEX
1641 Worthington Road
West Palm Beach, Florida

© COPYRIGHT 2010
THESE DRAWINGS ARE FOR THE
EXCLUSIVE USE OF GLIDDEN SPINA
& PARTNERS, INC. AND MAY NOT BE
REPRODUCED, COPIED, OR USED
IN ANY MANNER WITHOUT THE
EXPRESS WRITTEN CONSENT OF
GLIDDEN SPINA & PARTNERS, INC.
ALL RIGHTS RESERVED

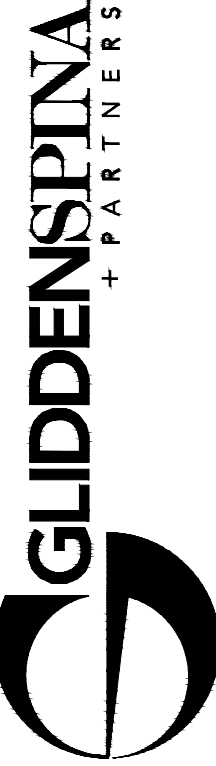

Architecture • Interior Design
John Glidden #86539 • Keith M. Spina # AT13419

1401 FORUM WAY, SUITE #100
WEST PALM BEACH, FLORIDA 33401
561.684.6844 • Fax 561.684.5594
gliddenspina.com
FL Lic. # AA26002399