


UPPER HVAC PLAN

SCALE: 1/8"=1'-0"

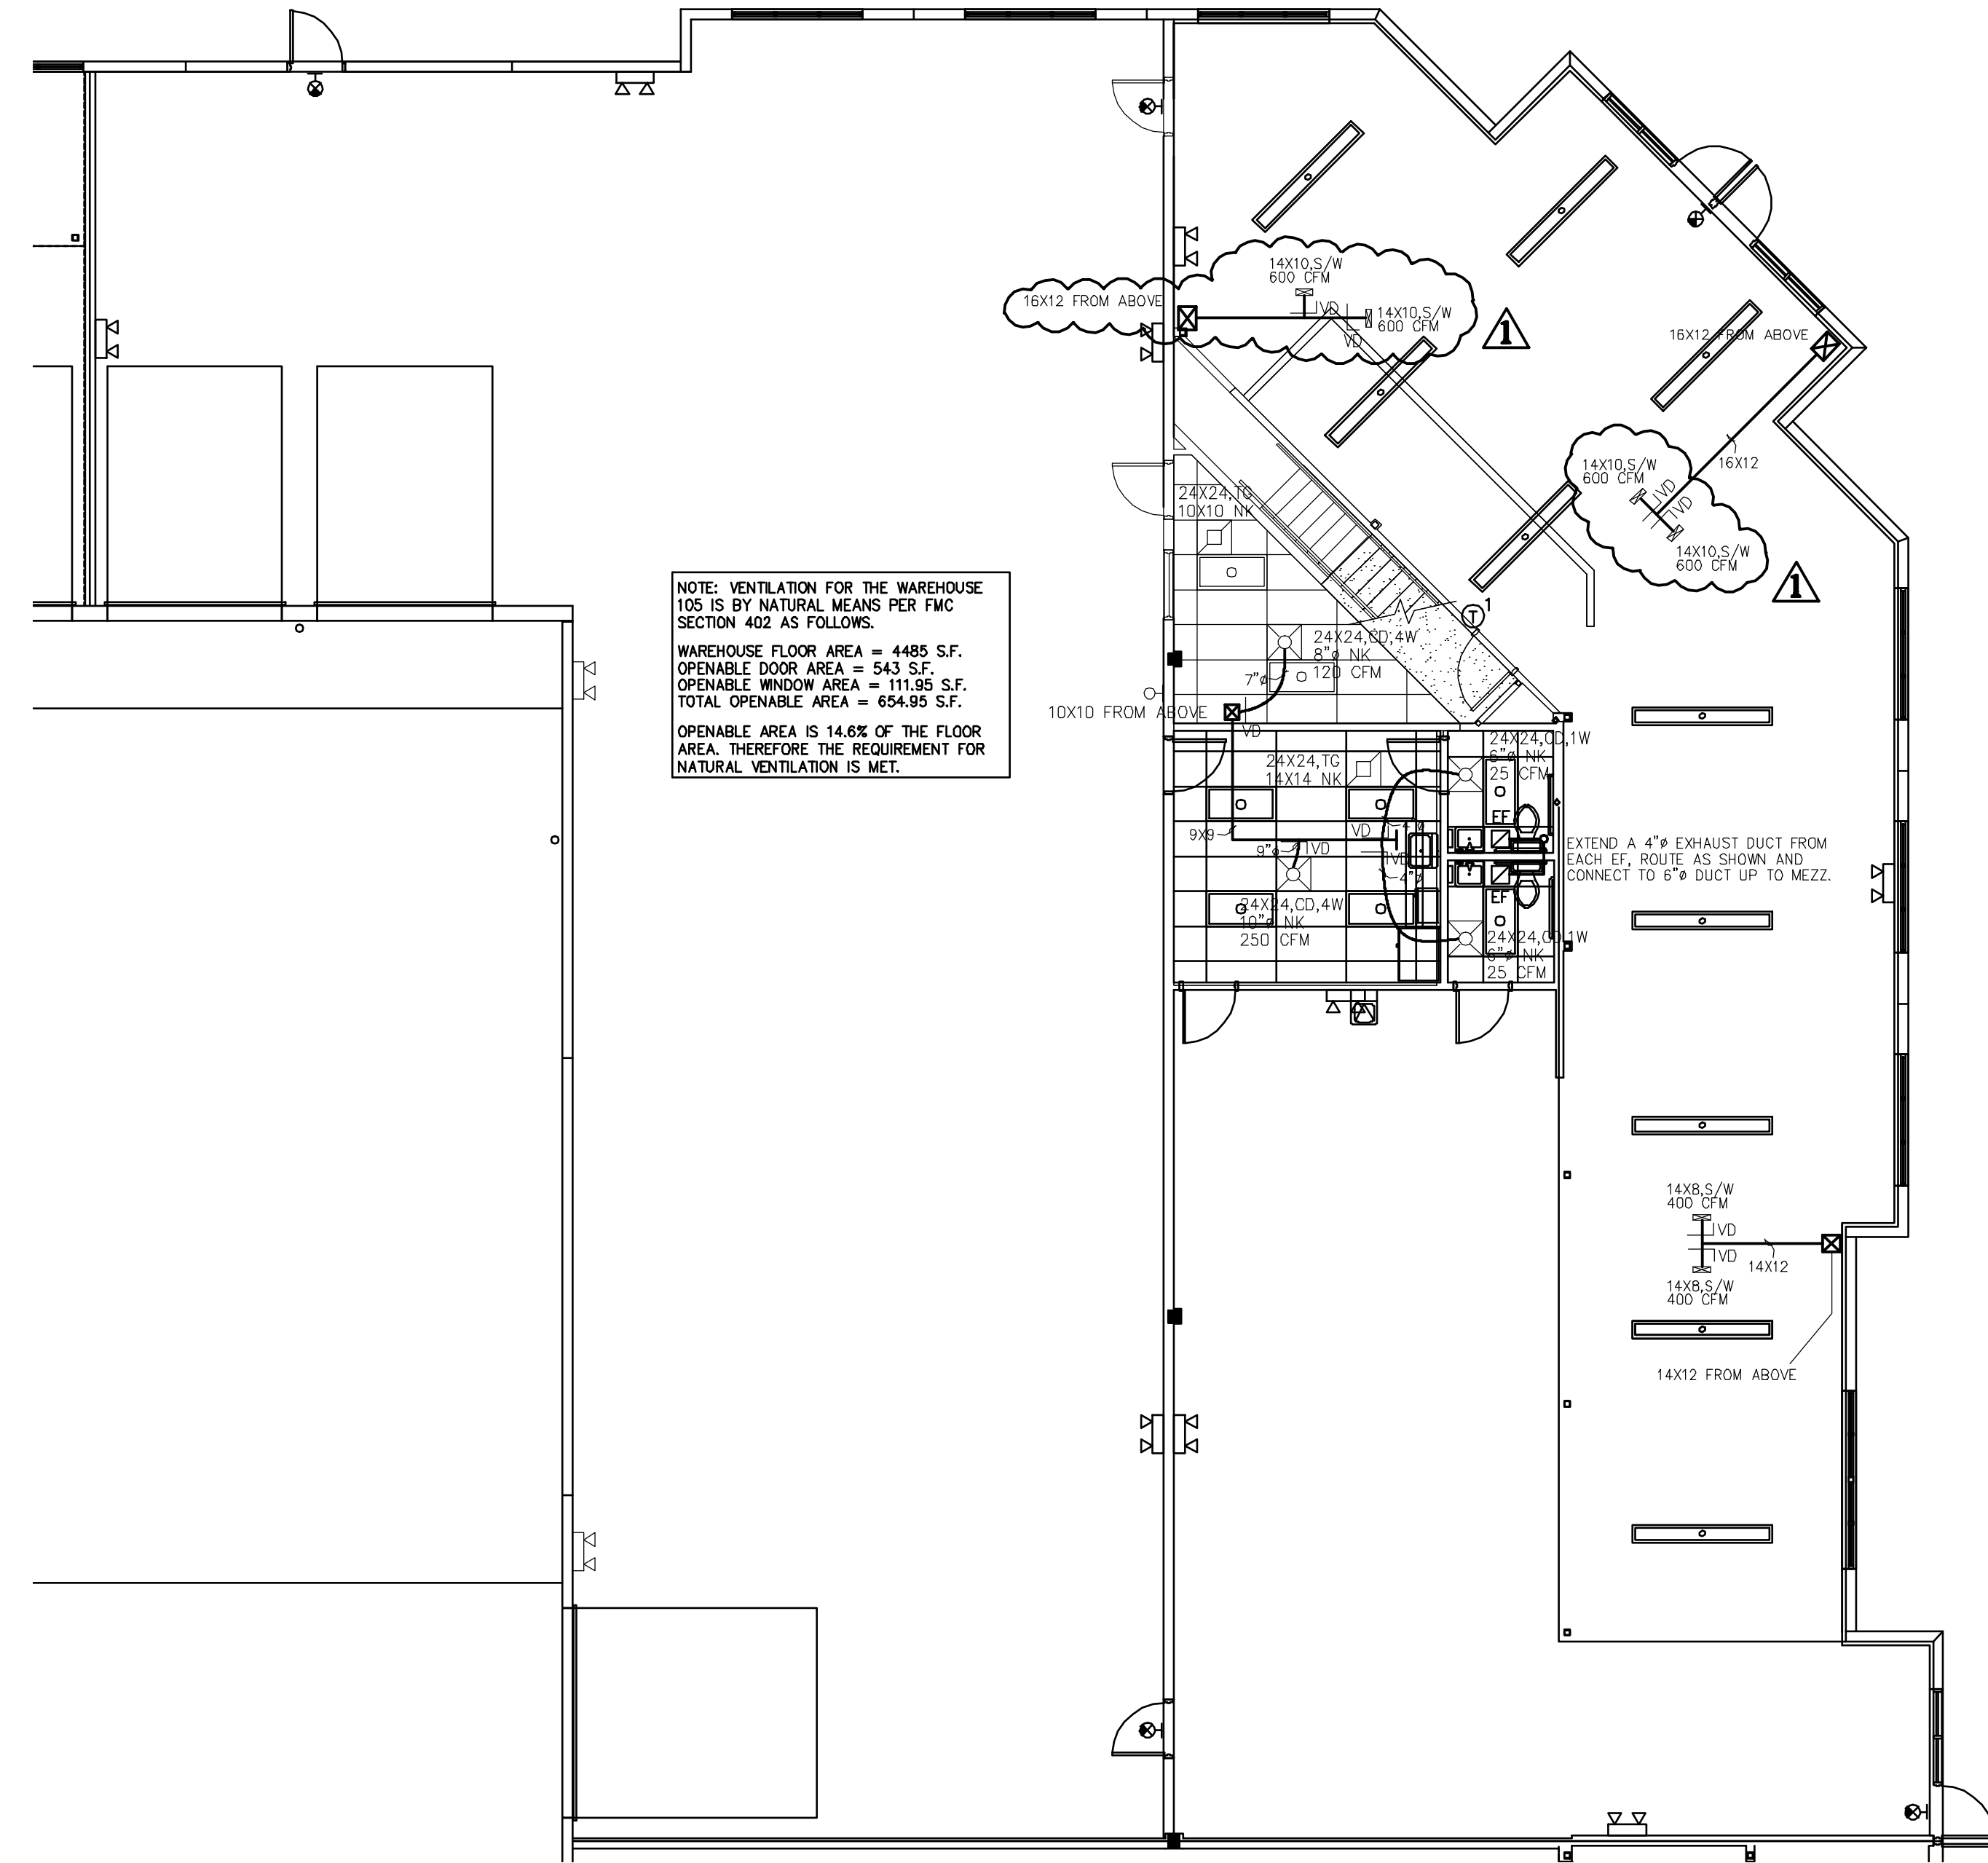

LOWER HVAC PLAN

SCALE: 1/8"=1'-0"

tercilla **courtemanche** architects

Tenant Improvement for:
Building B, Bay 6
 Southern Park of Commerce
 Palm Beach County, FL

AA 0009414
 2047 vista parkway, suite 100
 west palm beach, florida 33411 ph: 561.478.4457 fx: 561.478.4102

commission	29012
date:	6-03-09
revision	date
no. 1	7-20-09
2	
3	
4	
5	
6	
7	
8	

drawing **M1.1**
 copyright 2009

CHANE, INC.
 CONSULTING ENGINEERS
 2705 PARK STREET
 LAKE WORTH, FL 33460
 E-MAIL CHANEINC@AOL.COM
 TEL. 561-586-4003 FAX 561-586-5688
 CERTIFICATE OF AUTHORIZATION #2559
 ARNOLD I. CHANE, PE #10024
 DAVID R. JONES, PE #41042
 HOWARD L. CHANE, PE #22467

THE CONTENTS OF THESE DOCUMENTS, INCLUDING THE DESIGN ARE COPYRIGHTED AND PROPRIETARY. THE ARCHITECT SHALL USE ALL LEGAL AGENCIES AVAILABLE TO PROTECT SAID COPYRIGHT. ANY USE NOT AUTHORIZED IN WRITING BY THE ARCHITECT IS PROHIBITED.

12/20/09 12:00:00 PM 2009/07/20 12:00:00 PM 2009/07/20 12:00:00 PM